




- GENERAL NOTES:
- SMOKE GUARD FIRE RATED UNITS (HOUSINGS & SIDE GUIDES) TO BE MOUNTED TO A FINISHED, FIRE RATED ASSEMBLY OR STRUCTURE PER YOUR APPLICATION.
 - CLIENT TO PROVIDE CONTINUOUS MOUNTING SURFACE FOR STRUCTURAL AND SHEET METAL ATTACHMENT.
 - TOLERANCE: FLOOR TO CEILING VARIANCE MUST BE WITHIN +/- 1/2" ACROSS LENGTH OF MACHINE..
 - ORDER LENGTHS TO BE AT 1/4" INCREMENTS ONLY.
 - DIMENSIONS DO NOT INCLUDE HEADS OF EXTERNAL FASTENERS.
 - 12 GA. STEEL TOP MOUNTING PLATE
 - CONTROLLER CONDUIT BY OTHERS
 - CONTROLLER CABLE PROVIDED
 - PROVIDE ACCESS TO CONTROLLER
 - CONTROLLER MOUNTING SUBSTRATE BY OTHERS
 - MAX 30 CONDUIT FEET FROM MAIN CONTROLLER TO HOUSING
 - FIRE RATING FOR ENCLOSURE ABOVE HOUSING DESIGNED BY OTHERS.
 - STATIC/DYNAMIC SYSTEM WEIGHT, 40 LBS/FT.
 - 4"-6" CLEARANCE REQ'D AT CURTAIN TRAY FOR INSTALLATION AND SERVICE
 - INTERNAL MOTORS ARE ACCESSIBLE THROUGH HOUSING OPENING WHEN UNIT IS DEPLOYED.

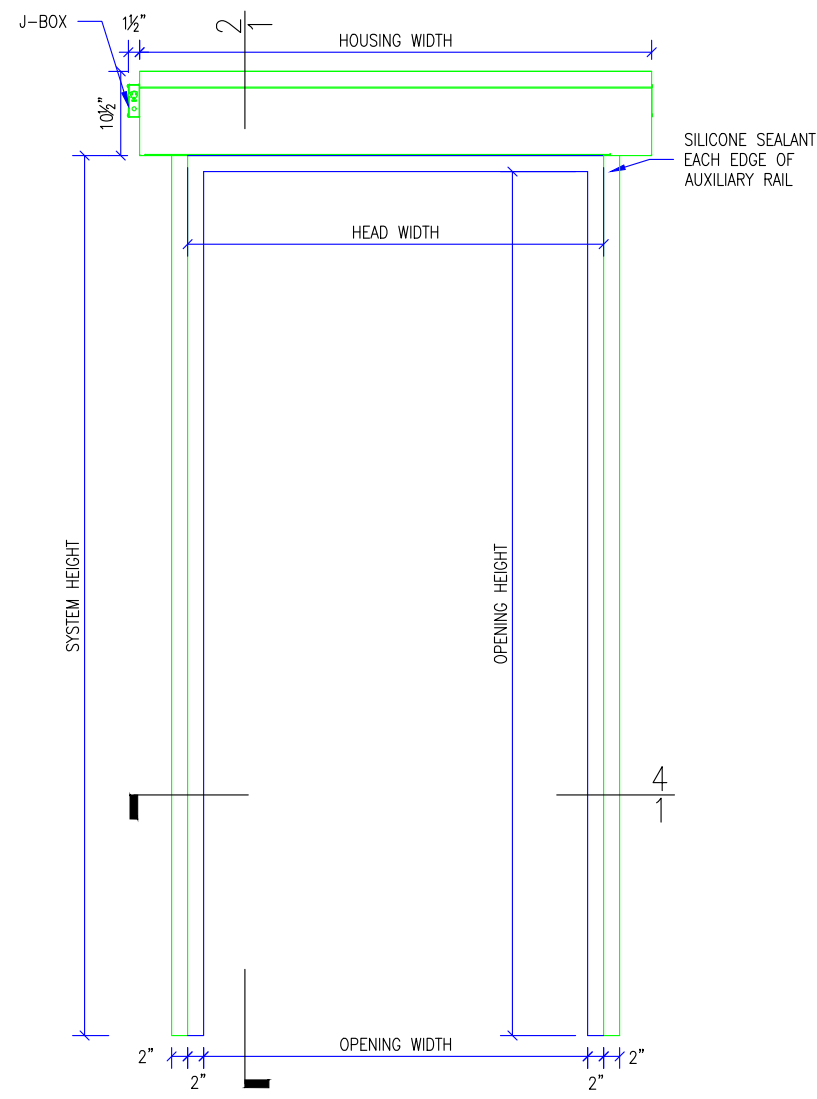


① M200 ELEVATION
SCALE: 1/2" = 1'-0"

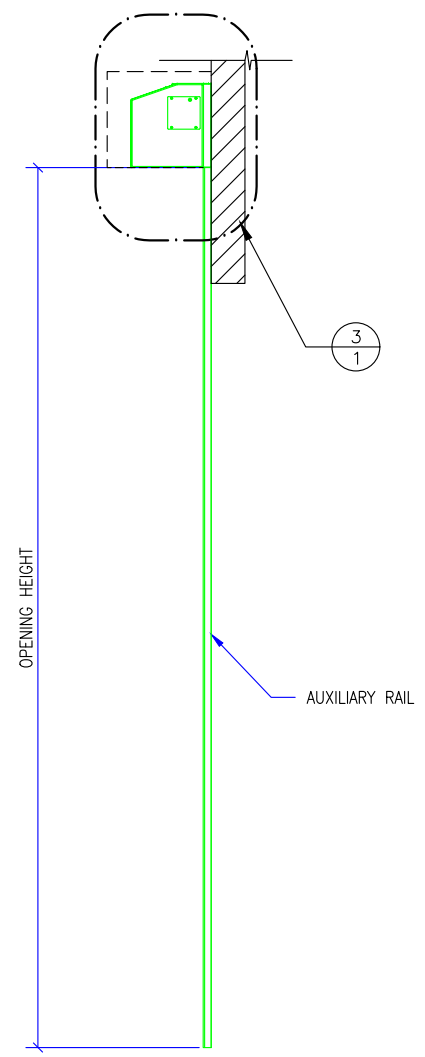

② M200 SECTION DETAIL
SCALE: 1/2" = 1'-0"

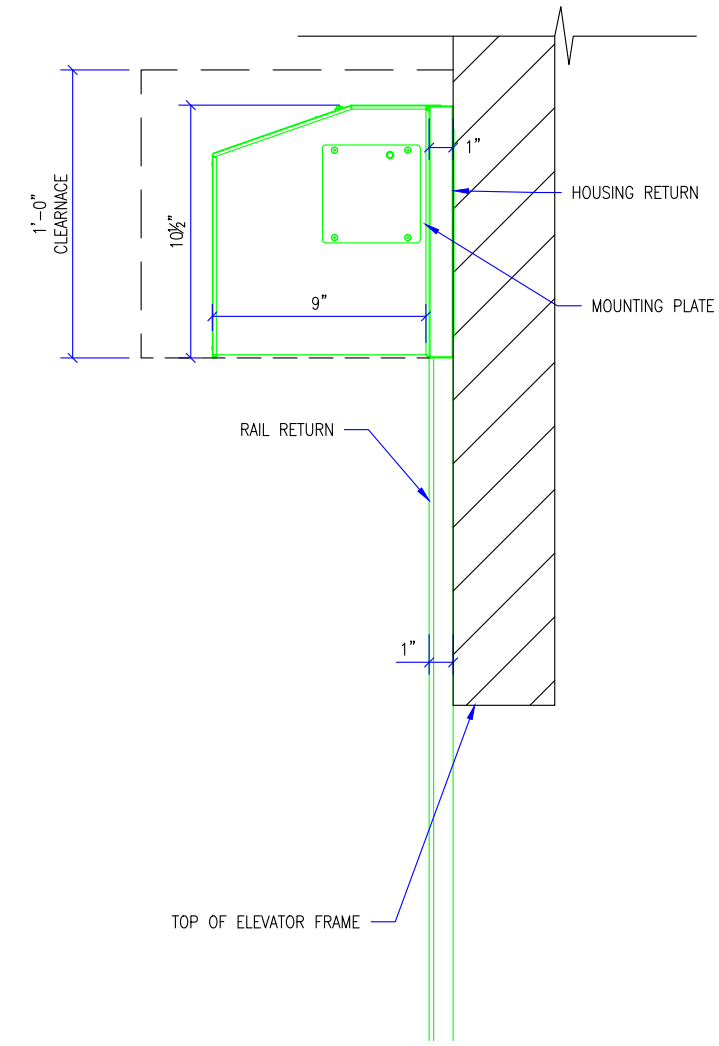

③ M200 HOUSING DETAIL
SCALE: 1 1/2" = 1'-0"

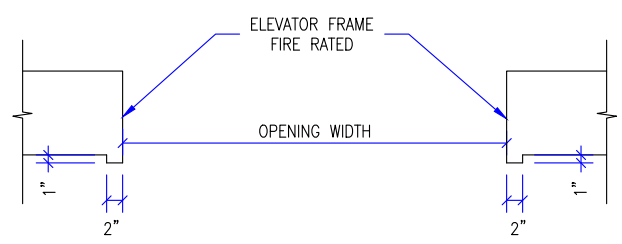

④ M200-JAMB SECTION DETAIL
SCALE: 1/2" = 1'-0"

REVISION		
REVISION NUMBER	REVISION DATE	REVISION DESCRIPTION
D1	5.9.19	INITIAL RELEASE
---	---	---

QUOTE: ----
CONFIGURATION: ----
PROJECT: ----
DIST.: ----


DESIGN SET: D1	SIZE B
MODEL: M200	SHEET 1 OF 5
SHEET TITLE: M200 DETAILS	
DRAWN: TLM	5.9.2019

THESE DRAWINGS SHOW OUR INTERPRETATION OF THE PRINCIPAL PLANS AND SPECIFICATIONS. THEY ARE SUBMITTED AS CHECK PRINTS REQUIRING REVIEW AND POSSIBLE REVISIONS TO DETAILS AND/OR DIMENSIONS. BEFORE FABRICATION OF MATERIALS CAN BEGIN, DRAWING PACKAGE MUST MATCH O.P.M. ORDER AND BE RETURNED SIGNED AND DATED. IF THERE ARE SIZE DISCREPANCIES BETWEEN THIS DRAWING PACKAGE AND O.P.M. ORDER, THESE DRAWINGS SUPERCEDE O.P.M. DIMENSIONS. IF CONSIDERABLY DIFFERENT, A RE-SUBMITTAL OF O.P.M. ORDER WILL BE REQUIRED. THIS SIGNATURE INDICATES PURCHASER'S FULL ACCEPTANCE OF DETAILS SHOWN AND THE PRODUCT IN CONFORMANCE TO SAME. THESE DESIGNS AND DRAWINGS ARE THE EXCLUSIVE PROPERTY OF SMOKE GUARD, INC. AND ARE NOT TO BE USED OR DUPLICATED WITHOUT PERMISSIONS.



287 N. Maple Grove
Boise, ID 83704
800.574.0330
www.smokeguard.com

- GENERAL NOTES:
1. SMOKE GUARD FIRE RATED UNITS (HOUSINGS & SIDE GUIDES) TO BE MOUNTED TO A FINISHED, FIRE RATED ASSEMBLY OR STRUCTURE PER YOUR APPLICATION.
 2. CLIENT TO PROVIDE CONTINUOUS MOUNTING SURFACE FOR STRUCTURAL AND SHEET METAL ATTACHMENT.
 3. TOLERANCE: FLOOR TO CEILING VARIANCE MUST BE WITHIN +/- 1/2" ACROSS LENGTH OF MACHINE..
 4. ORDER LENGTHS TO BE AT 1/4" INCREMENTS ONLY.
 5. DIMENSIONS DO NOT INCLUDE HEADS OF EXTERNAL FASTENERS.
 6. 12 GA. STEEL TOP MOUNTING PLATE
 7. CONTROLLER CONDUIT BY OTHERS
 8. CONTROLLER CABLE PROVIDED
 9. PROVIDE ACCESS TO CONTROLLER
 10. CONTROLLER MOUNTING SUBSTRATE BY OTHERS
 11. MAX 30 CONDUIT FEET FROM MAIN CONTROLLER TO HOUSING
 12. FIRE RATING FOR ENCLOSURE ABOVE HOUSING DESIGNED BY OTHERS.
 13. STATIC/DYNAMIC SYSTEM WEIGHT, 40 LBS/FT.
 14. 4"-6" CLEARANCE REQ.'D AT CURTAIN TRAY FOR INSTALLATION AND SERVICE
 15. INTERNAL MOTORS ARE ACCESSIBLE THROUGH HOUSING OPENING WHEN UNIT IS DEPLOYED.

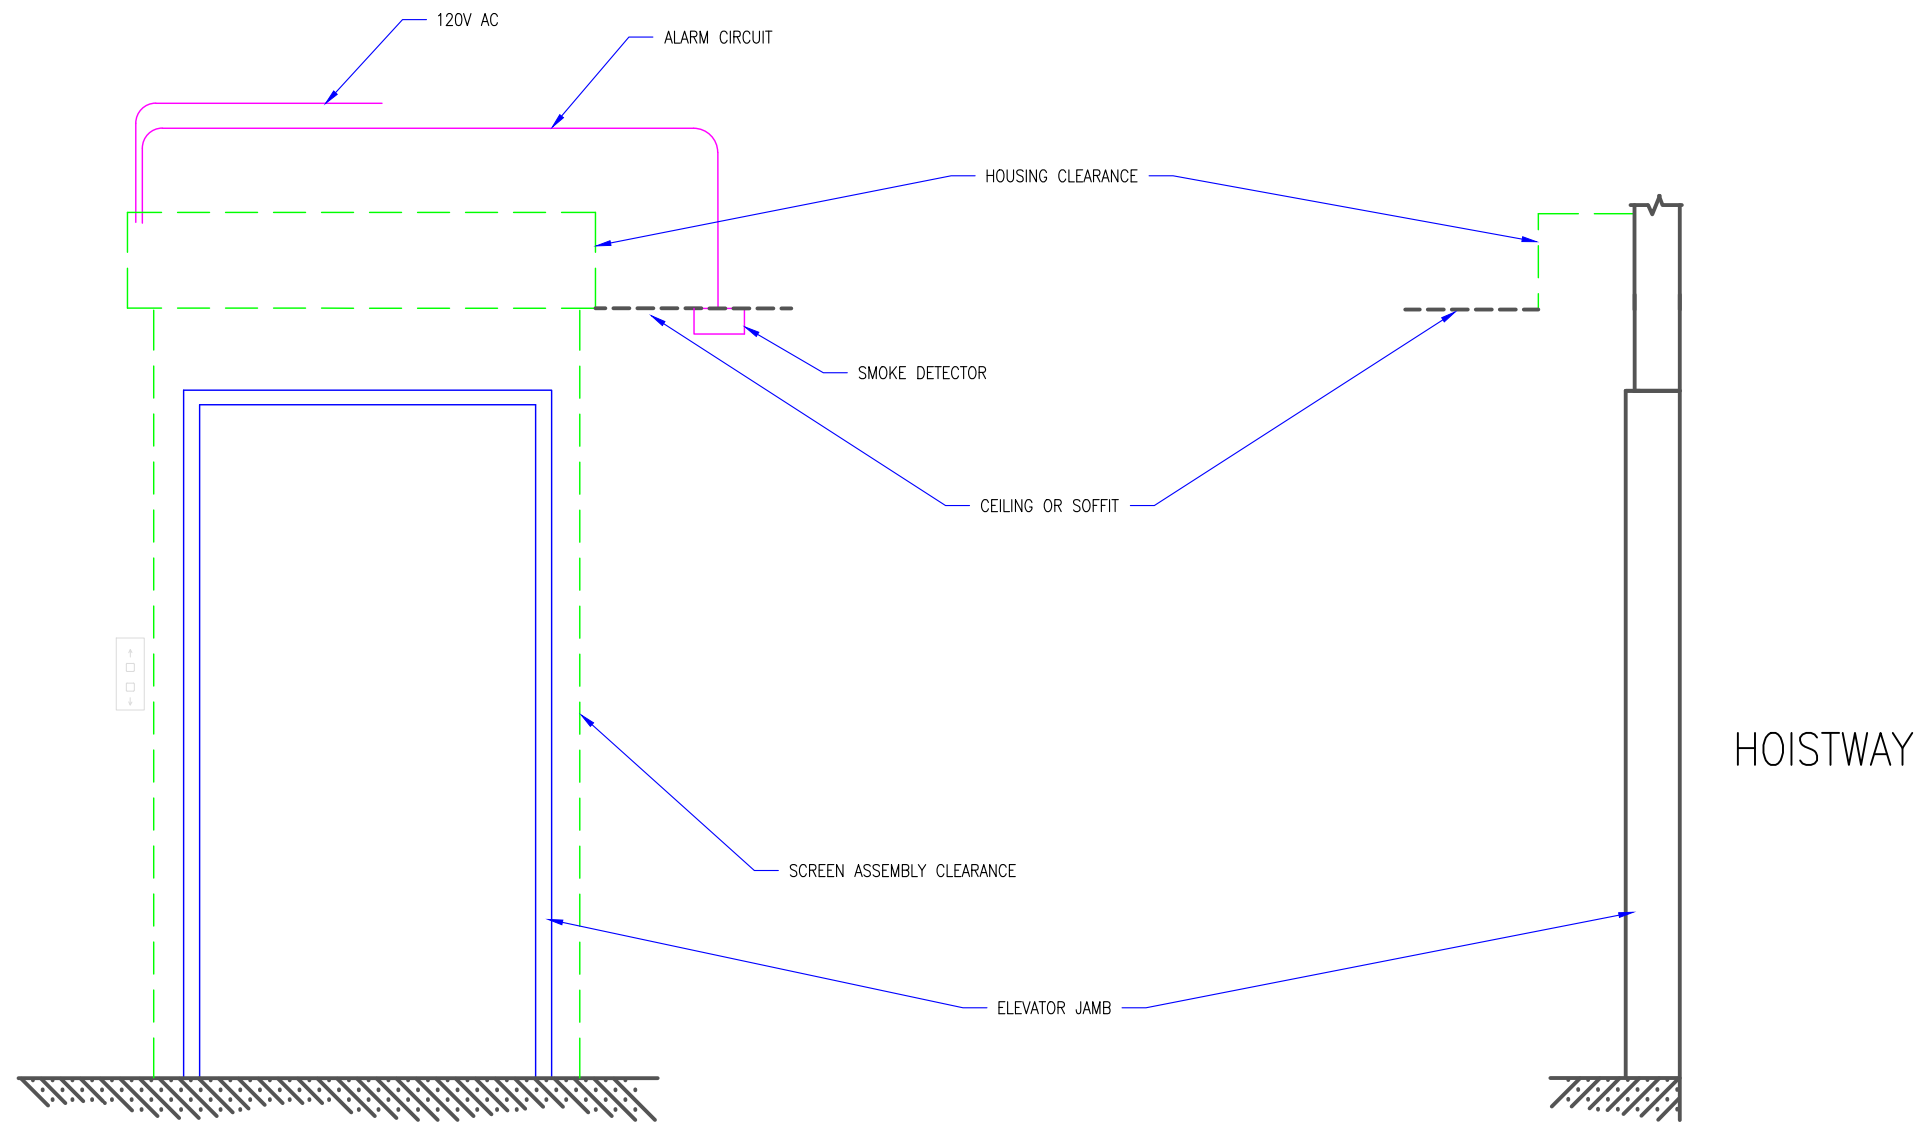

LANDING ELEVATION

SECTION

1 M200 ELEVATION DETAILS
SCALE: 1/2" = 1'-0"

REVISION

REVISION NUMBER	REVISION DATE	REVISION DESCRIPTION
D1	5.9.19	INITIAL RELEASE
----	----	----

QUOTE: ----
CONFIGURATION: ----
PROJECT: ----
DIST.: ----

DESIGN SET: D1

SIZE
B

MODEL: M200

SHEET TITLE:
M200 ELEVATION DETAILS

SHEET
2 OF 5

DRAWN: TLM 5.9.2019


THESE DRAWINGS SHOW OUR INTERPRETATION OF THE PRINCIPAL PLANS AND SPECIFICATIONS. THEY ARE SUBMITTED AS CHECK PRINTS REQUIRING REVIEW AND POSSIBLE REVISIONS TO DETAILS AND/OR DIMENSIONS. BEFORE FABRICATION OF MATERIALS CAN BEGIN, DRAWING PACKAGE MUST MATCH O.P.M. ORDER AND BE RETURNED SIGNED AND DATED. IF THERE ARE SIZE DISCREPANCIES BETWEEN THIS DRAWING PACKAGE AND O.P.M. ORDER, THESE DRAWING SUPERCEDE O.P.M. DIMENSIONS. IF CONSIDERABLY DIFFERENT, A RE-SUBMITTAL OF O.P.M. ORDER WILL BE REQUIRED. THIS SIGNATURE INDICATES PURCHASER'S FULL ACCEPTANCE OF DETAILS SHOWN AND THE PRODUCT IN CONFORMANCE TO SAME. THESE DESIGNS AND DRAWINGS ARE THE EXCLUSIVE PROPERTY OF SMOKE GUARD, INC. AND ARE NOT TO BE USED OR DUPLICATED WITHOUT PERMISSIONS.

PAPER SIZE: 11 X 17




287 N. Maple Grove
Boise, ID 83704
800.574.0330
www.smokeguard.com

- GENERAL NOTES:
- SMOKE GUARD FIRE RATED UNITS (HOUSINGS & SIDE GUIDES) TO BE MOUNTED TO A FINISHED, FIRE RATED ASSEMBLY OR STRUCTURE PER YOUR APPLICATION.
 - CLIENT TO PROVIDE CONTINUOUS MOUNTING SURFACE FOR STRUCTURAL AND SHEET METAL ATTACHMENT.
 - TOLERANCE: FLOOR TO CEILING VARIANCE MUST BE WITHIN +/- 1/2" ACROSS LENGTH OF MACHINE..
 - ORDER LENGTHS TO BE AT 1/4" INCREMENTS ONLY.
 - DIMENSIONS DO NOT INCLUDE HEADS OF EXTERNAL FASTENERS.
 - 12 GA. STEEL TOP MOUNTING PLATE
 - CONTROLLER CONDUIT BY OTHERS
 - CONTROLLER CABLE PROVIDED
 - PROVIDE ACCESS TO CONTROLLER
 - CONTROLLER MOUNTING SUBSTRATE BY OTHERS
 - MAX 30 CONDUIT FEET FROM MAIN CONTROLLER TO HOUSING
 - FIRE RATING FOR ENCLOSURE ABOVE HOUSING DESIGNED BY OTHERS.
 - STATIC/DYNAMIC SYSTEM WEIGHT, 40 LBS/FT.
 - 4"-6" CLEARANCE REQ.'D AT CURTAIN TRAY FOR INSTALLATION AND SERVICE
 - INTERNAL MOTORS ARE ACCESSIBLE THROUGH HOUSING OPENING WHEN UNIT IS DEPLOYED.

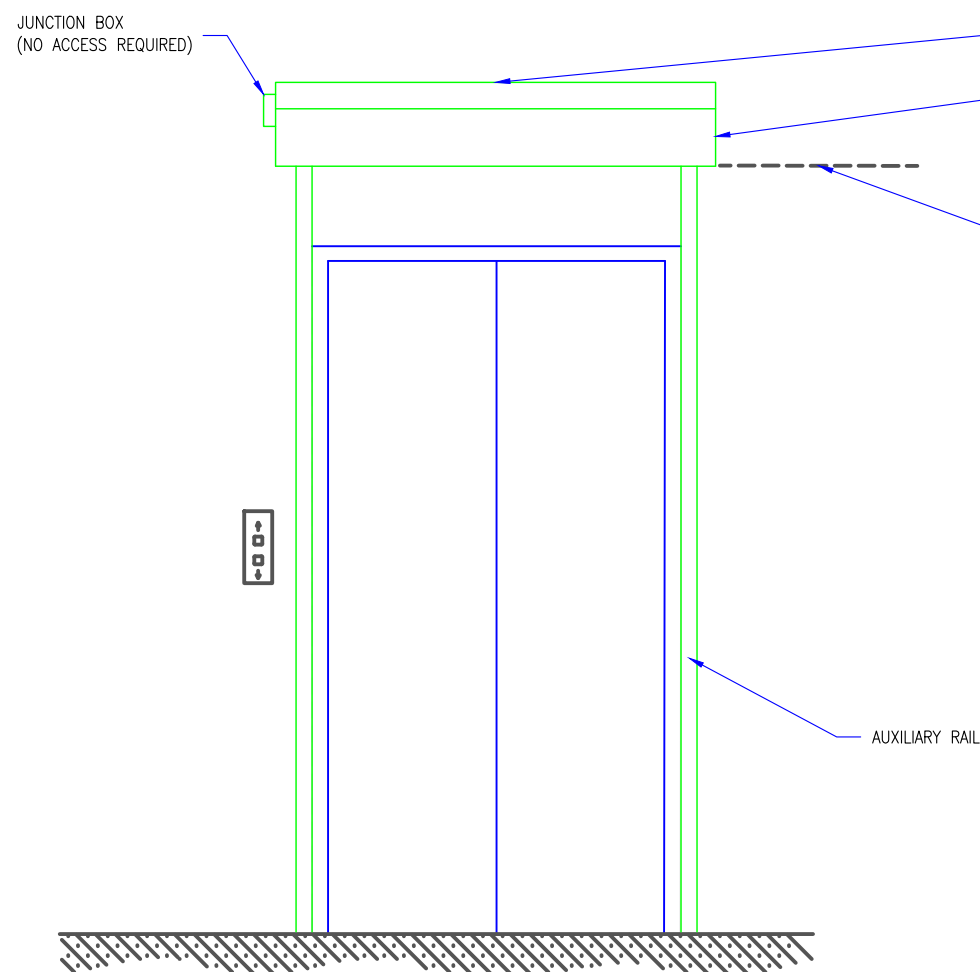

LANDING ELEVATION - READY STATE

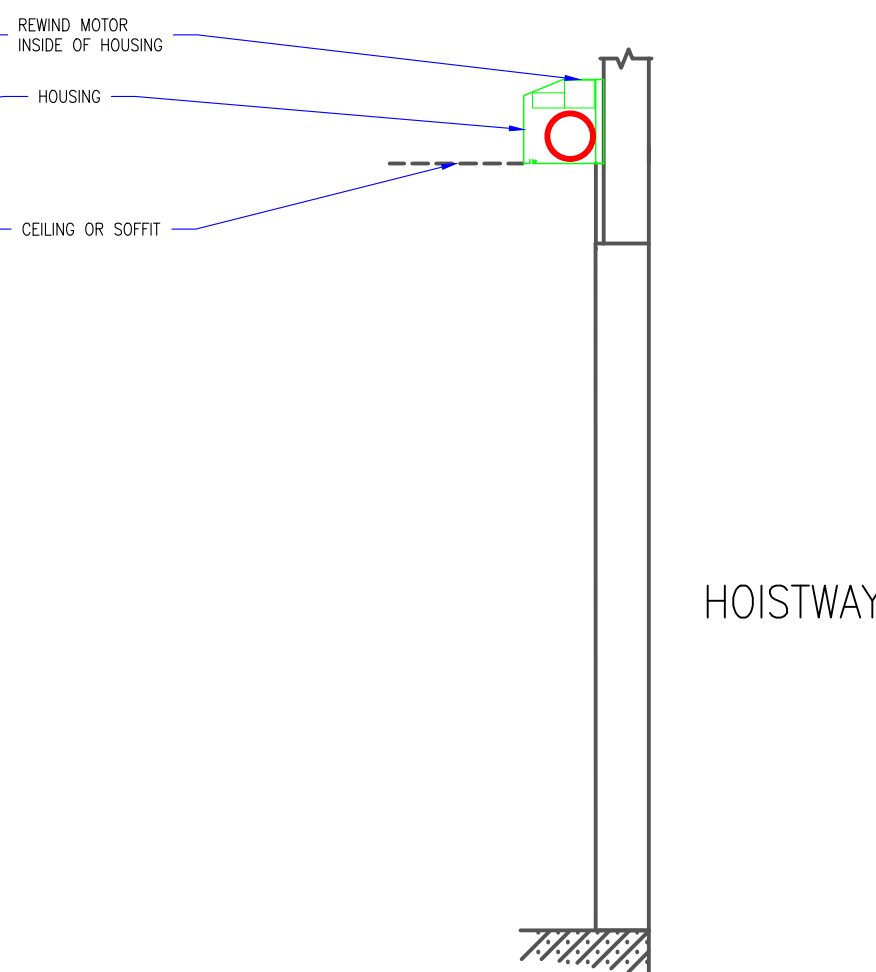

SECTION - READY STATE

1 M200 READY STATE DETAILS
SCALE: 1/2" = 1'-0"

REVISION

REVISION NUMBER	REVISION DATE	REVISION DESCRIPTION
D1	5.9.19	INITIAL RELEASE
----	----	----

QUOTE: ----
CONFIGURATION: ----
PROJECT: ----
DIST.: ----

DESIGN SET: D1

SIZE
B

MODEL: M200

SHEET TITLE:
M200 READY STATE DETAILS


SHEET
3 OF 5

DRAWN: TLM 5.9.2019

THESE DRAWINGS SHOW OUR INTERPRETATION OF THE PRINCIPAL PLANS AND SPECIFICATIONS. THEY ARE SUBMITTED AS CHECK PRINTS REQUIRING REVIEW AND POSSIBLE REVISIONS TO DETAILS AND/OR DIMENSIONS. BEFORE FABRICATION OF MATERIALS CAN BEGIN, DRAWING PACKAGE MUST MATCH O.P.M. ORDER AND BE RETURNED SIGNED AND DATED. IF THERE ARE SIZE DISCREPANCIES BETWEEN THIS DRAWING PACKAGE AND O.P.M. ORDER, THESE DRAWING SUPERCEDE O.P.M. DIMENSIONS. IF CONSIDERABLY DIFFERENT, A RE-SUBMITTAL OF O.P.M. ORDER WILL BE REQUIRED. THIS SIGNATURE INDICATES PURCHASER'S FULL ACCEPTANCE OF DETAILS SHOWN AND THE PRODUCT IN CONFORMANCE TO SAME. THESE DESIGNS AND DRAWINGS ARE THE EXCLUSIVE PROPERTY OF SMOKE GUARD, INC. AND ARE NOT TO BE USED OR DUPLICATED WITHOUT PERMISSIONS.

PAPER SIZE: 11 X 17

- GENERAL NOTES:
1. SMOKE GUARD FIRE RATED UNITS (HOUSINGS & SIDE GUIDES) TO BE MOUNTED TO A FINISHED, FIRE RATED ASSEMBLY OR STRUCTURE PER YOUR APPLICATION.
 2. CLIENT TO PROVIDE CONTINUOUS MOUNTING SURFACE FOR STRUCTURAL AND SHEET METAL ATTACHMENT.
 3. TOLERANCE: FLOOR TO CEILING VARIANCE MUST BE WITHIN +/- 1/2" ACROSS LENGTH OF MACHINE..
 4. ORDER LENGTHS TO BE AT 1/4" INCREMENTS ONLY.
 5. DIMENSIONS DO NOT INCLUDE HEADS OF EXTERNAL FASTENERS.
 6. 12 GA. STEEL TOP MOUNTING PLATE
 7. CONTROLLER CONDUIT BY OTHERS
 8. CONTROLLER CABLE PROVIDED
 9. PROVIDE ACCESS TO CONTROLLER
 10. CONTROLLER MOUNTING SUBSTRATE BY OTHERS
 11. MAX 30 CONDUIT FEET FROM MAIN CONTROLLER TO HOUSING
 12. FIRE RATING FOR ENCLOSURE ABOVE HOUSING DESIGNED BY OTHERS.
 13. STATIC/DYNAMIC SYSTEM WEIGHT, 40 LBS/FT.
 14. 4"-6" CLEARANCE REQ.'D AT CURTAIN TRAY FOR INSTALLATION AND SERVICE
 15. INTERNAL MOTORS ARE ACCESSIBLE THROUGH HOUSING OPENING WHEN UNIT IS DEPLOYED.

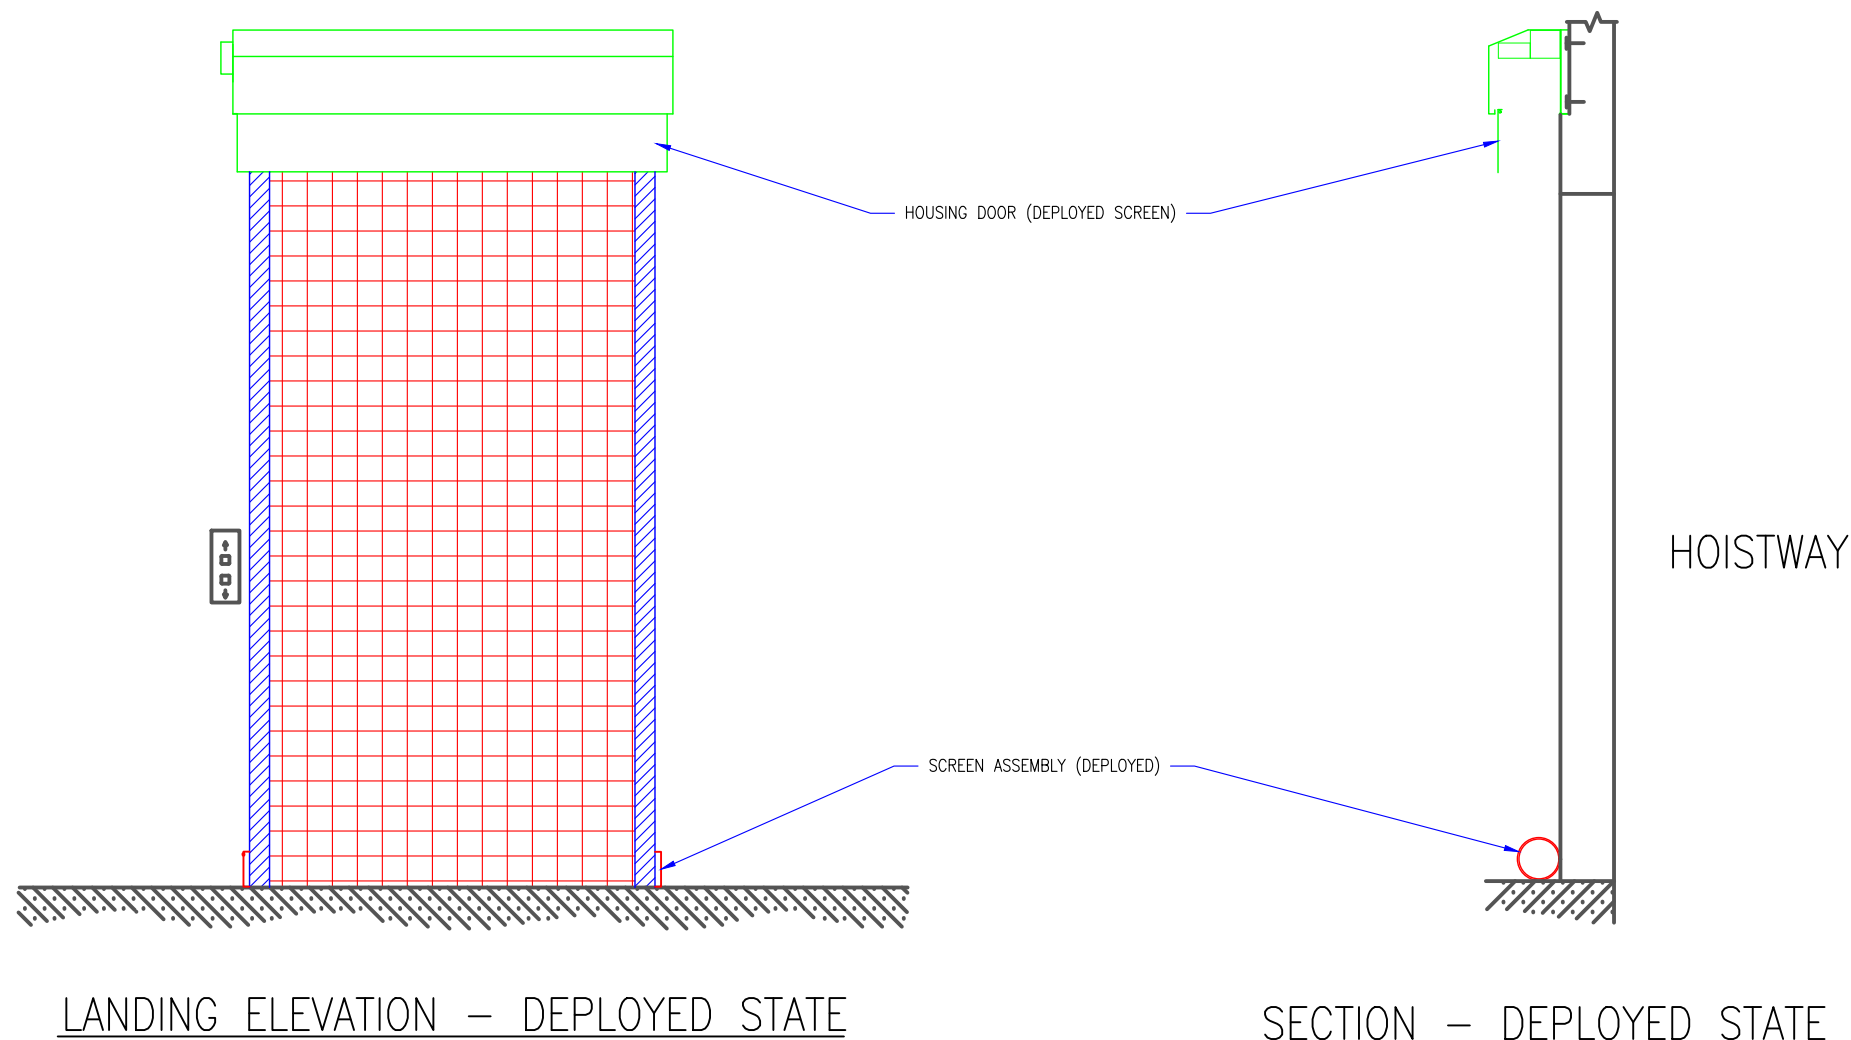

① M200 DEPLOYED DETAIL
SCALE: 1/2" = 1'-0"

REVISION		
REVISION NUMBER	REVISION DATE	REVISION DESCRIPTION
D1	5.9.19	INITIAL RELEASE
----	----	----

QUOTE: ----
CONFIGURATION: ----
PROJECT: ----
DIST.: ----

DESIGN SET: D1	SIZE B
MODEL: M200	SHEET
SHEET TITLE: M200 DEPLOYED DETAILS	4 OF 5
DRAWN: TLM	5.9.2019


THESE DRAWINGS SHOW OUR INTERPRETATION OF THE PRINCIPAL PLANS AND SPECIFICATIONS. THEY ARE SUBMITTED AS CHECK PRINTS REQUIRING REVIEW AND POSSIBLE REVISIONS TO DETAILS AND/OR DIMENSIONS. BEFORE FABRICATION OF MATERIALS CAN BEGIN, DRAWING PACKAGE MUST MATCH O.P.M. ORDER AND BE RETURNED SIGNED AND DATED. IF THERE ARE SIZE DISCREPANCIES BETWEEN THIS DRAWING PACKAGE AND O.P.M. ORDER, THESE DRAWING SUPERCEDE O.P.M. DIMENSIONS. IF CONSIDERABLY DIFFERENT, A RE-SUBMITTAL OF O.P.M. ORDER WILL BE REQUIRED. THIS SIGNATURE INDICATES PURCHASER'S FULL ACCEPTANCE OF DETAILS SHOWN AND THE PRODUCT IN CONFORMANCE TO SAME. THESE DESIGNS AND DRAWINGS ARE THE EXCLUSIVE PROPERTY OF SMOKE GUARD, INC. AND ARE NOT TO BE USED OR DUPLICATED WITHOUT PERMISSIONS.



287 N. Maple Grove
Boise, ID 83704
800.574.0330
www.smokeguard.com

- LEGEND:
- [A] MAIN, CONTROLLER (18"x14"x6"), PROVIDE ACCESS
 - [LV] LOW VOLTAGE, MAX 30 CONDUIT FT. BY OTHERS
 - [SD] SERVICE DISCONNECT, 120VAC, 20A BY OTHERS
 - [E1] HIGH VOLTAGE #1, 120V
 - [E2] HIGH VOLTAGE #2, 120V
 - [E3] HIGH VOLTAGE #3, 120V
 - [K] KEYED TEST DEPLOY SWITCH, BY S.G.
 - [R] RETRACT SWITCH
 - [FA] TO FIRE ALARM
 - [FS] TO FSCS
 - (H#) END OF HOUSING
 - (SG#) DATUM LINE, INSIDE OF HOUSING

- GENERAL NOTES:
1. SMOKE GUARD FIRE RATED UNITS (HOUSINGS & SIDE GUIDES) TO BE MOUNTED TO A FINISHED, FIRE RATED ASSEMBLY OR STRUCTURE PER YOUR APPLICATION.
 2. CLIENT TO PROVIDE CONTINUOUS MOUNTING SURFACE FOR STRUCTURAL AND SHEET METAL ATTACHMENT.
 3. TOLERANCE: FLOOR TO CEILING VARIANCE MUST BE WITHIN +/- 1/2" ACROSS LENGTH OF MACHINE..
 4. ORDER LENGTHS TO BE AT 1/4" INCREMENTS ONLY.
 5. DIMENSIONS DO NOT INCLUDE HEADS OF EXTERNAL FASTENERS.
 6. 12 GA. STEEL TOP MOUNTING PLATE
 7. CONTROLLER CONDUIT BY OTHERS
 8. CONTROLLER CABLE PROVIDED
 9. PROVIDE ACCESS TO CONTROLLER
 10. CONTROLLER MOUNTING SUBSTRATE BY OTHERS
 11. MAX 30 CONDUIT FEET FROM MAIN CONTROLLER TO HOUSING
 12. FIRE RATING FOR ENCLOSURE ABOVE HOUSING DESIGNED BY OTHERS.
 13. STATIC/DYNAMIC SYSTEM WEIGHT, 40 LBS/FT.
 14. 4"-6" CLEARANCE REQ'D AT CURTAIN TRAY FOR INSTALLATION AND SERVICE
 15. INTERNAL MOTORS ARE ACCESSIBLE THROUGH HOUSING OPENING WHEN UNIT IS DEPLOYED.

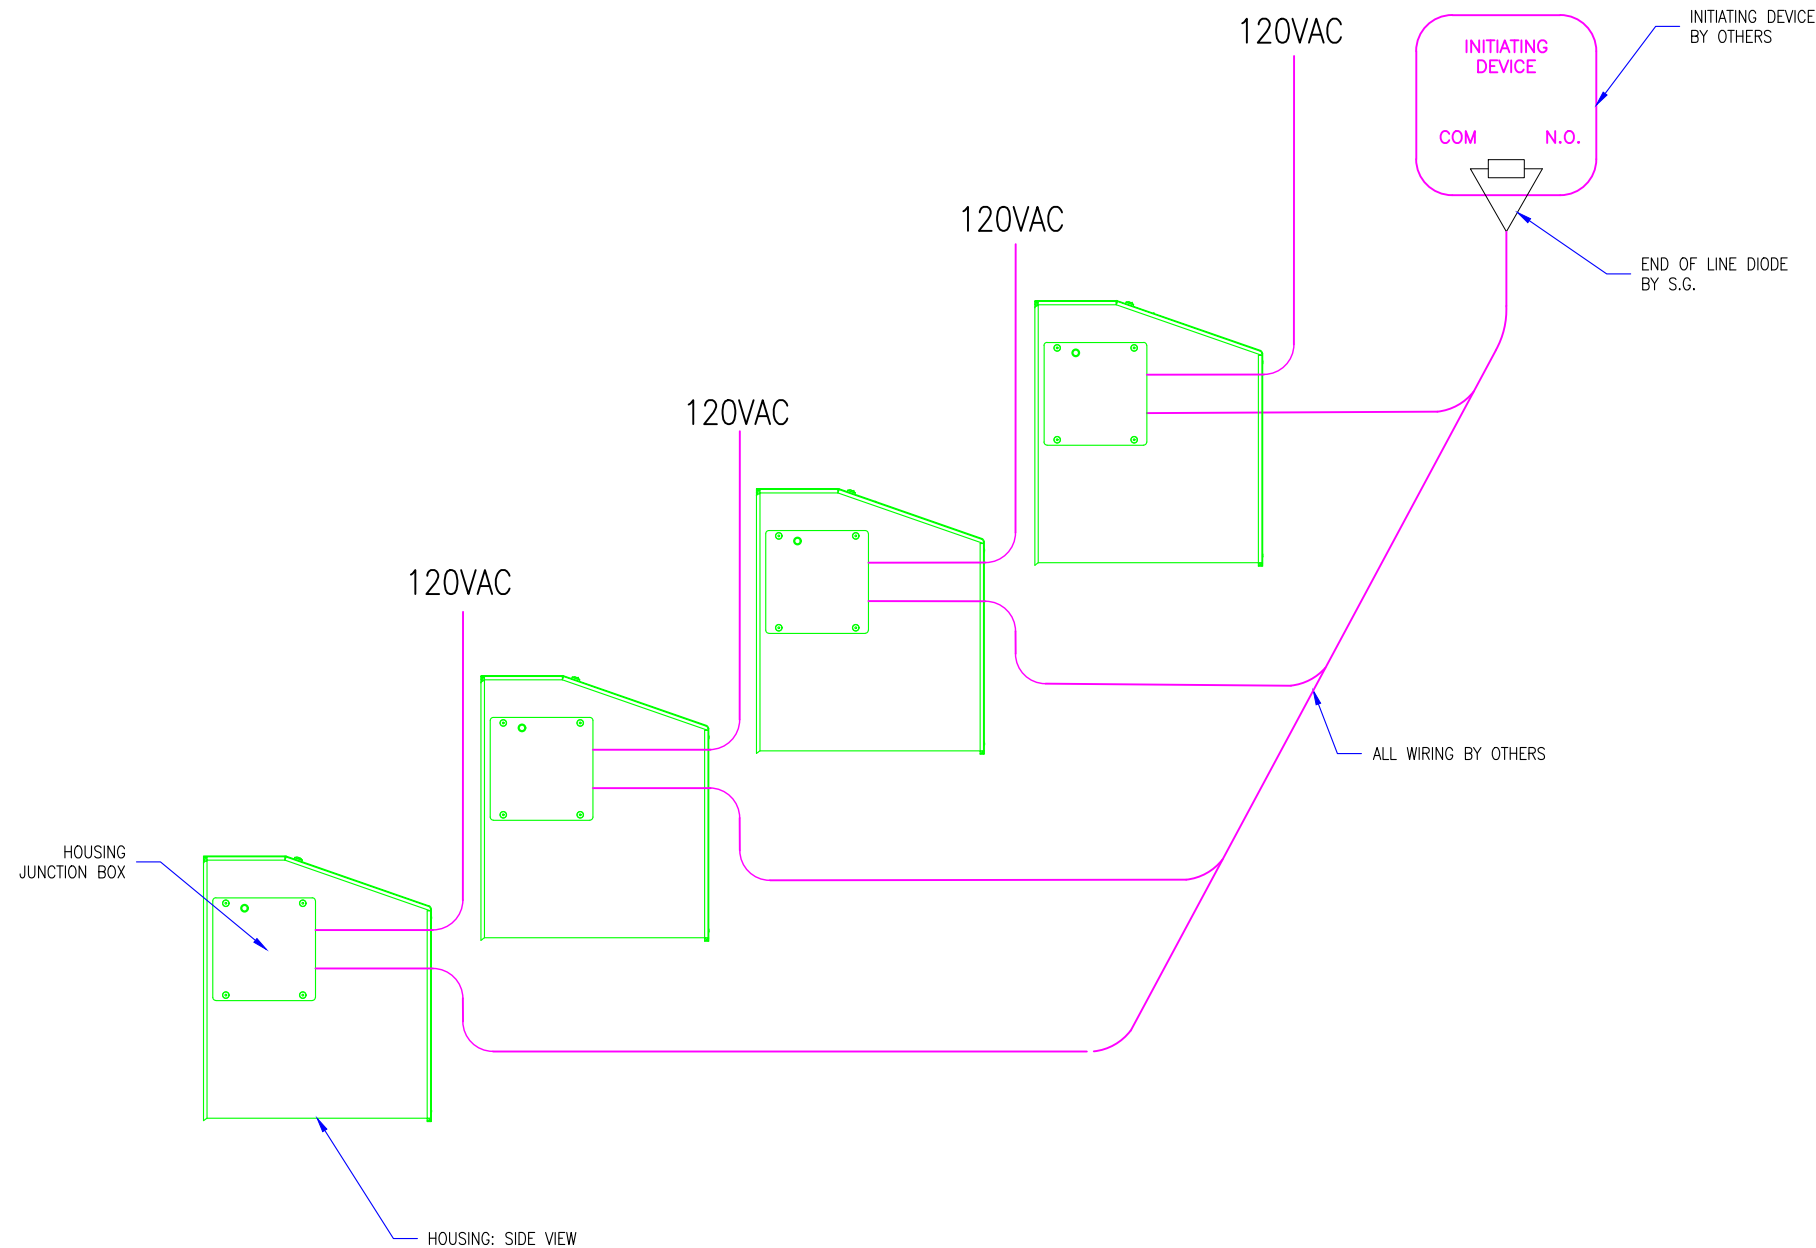

UP TO 4 HOUSINGS CAN BE WIRED TO AN END-OF-LINE DIODE AT AN AUXILIARY CONTACT

① M200 ELECTRICAL DETAILS
SCALE: 3/4" = 1'-0"

REVISION

REVISION NUMBER	REVISION DATE	REVISION DESCRIPTION
D1	5.9.19	INITIAL RELEASE
----	----	----

QUOTE: ----
CONFIGURATION: ----
PROJECT: ----
DIST.: ----

DESIGN SET: D1	SIZE B
MODEL: M200	B
SHEET TITLE: M200 ELECTRICAL DETAIL	SHEET 5 OF 5
DRAWN: TLM	5.9.2019

THESE DRAWINGS SHOW OUR INTERPRETATION OF THE PRINCIPAL PLANS AND SPECIFICATIONS. THEY ARE SUBMITTED AS CHECK PRINTS REQUIRING REVIEW AND POSSIBLE REVISIONS TO DETAILS AND/OR DIMENSIONS. BEFORE FABRICATION OF MATERIALS CAN BEGIN, DRAWING PACKAGE MUST MATCH O.P.M. ORDER AND BE RETURNED SIGNED AND DATED. IF THERE ARE SIZE DISCREPANCIES BETWEEN THIS DRAWING PACKAGE AND O.P.M. ORDER, THESE DRAWING SUPERCEDE O.P.M. DIMENSIONS. IF CONSIDERABLY DIFFERENT, A RE-SUBMITTAL OF O.P.M. ORDER WILL BE REQUIRED. THIS SIGNATURE INDICATES PURCHASER'S FULL ACCEPTANCE OF DETAILS SHOWN AND THE PRODUCT IN CONFORMANCE TO SAME. THESE DESIGNS AND DRAWINGS ARE THE EXCLUSIVE PROPERTY OF SMOKE GUARD, INC. AND ARE NOT TO BE USED OR DUPLICATED WITHOUT PERMISSIONS.

PAPER SIZE: 11 X 17