
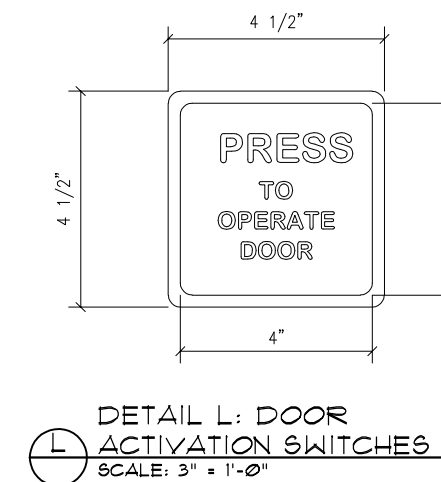
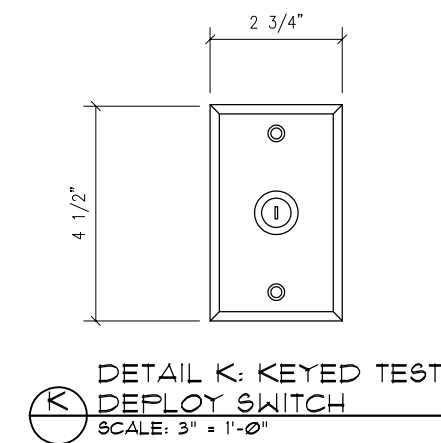


- GENERAL NOTES:
- SMOKE GUARD TO PROVIDE:
 - MAIN CONTROLLER STATION
 - END-OF-LINE DIODE
 - ALL REMAINING ELECTRICAL BY OTHERS.
 - DEFAULT LOCATION OF MAIN MOTOR IS RIGHT SIDE VIEWED FROM FRONT ELEVATION. LEFT SIDE IS OPTIONAL UPON REQUEST.
 - CONTROLLER DIMENSIONS ARE 18"x14.25"x 6", REFER TO SUPPLEMENTARY DOCUMENTATION FOR WIRING SPECIFICS & MOUNTING DETAILS.

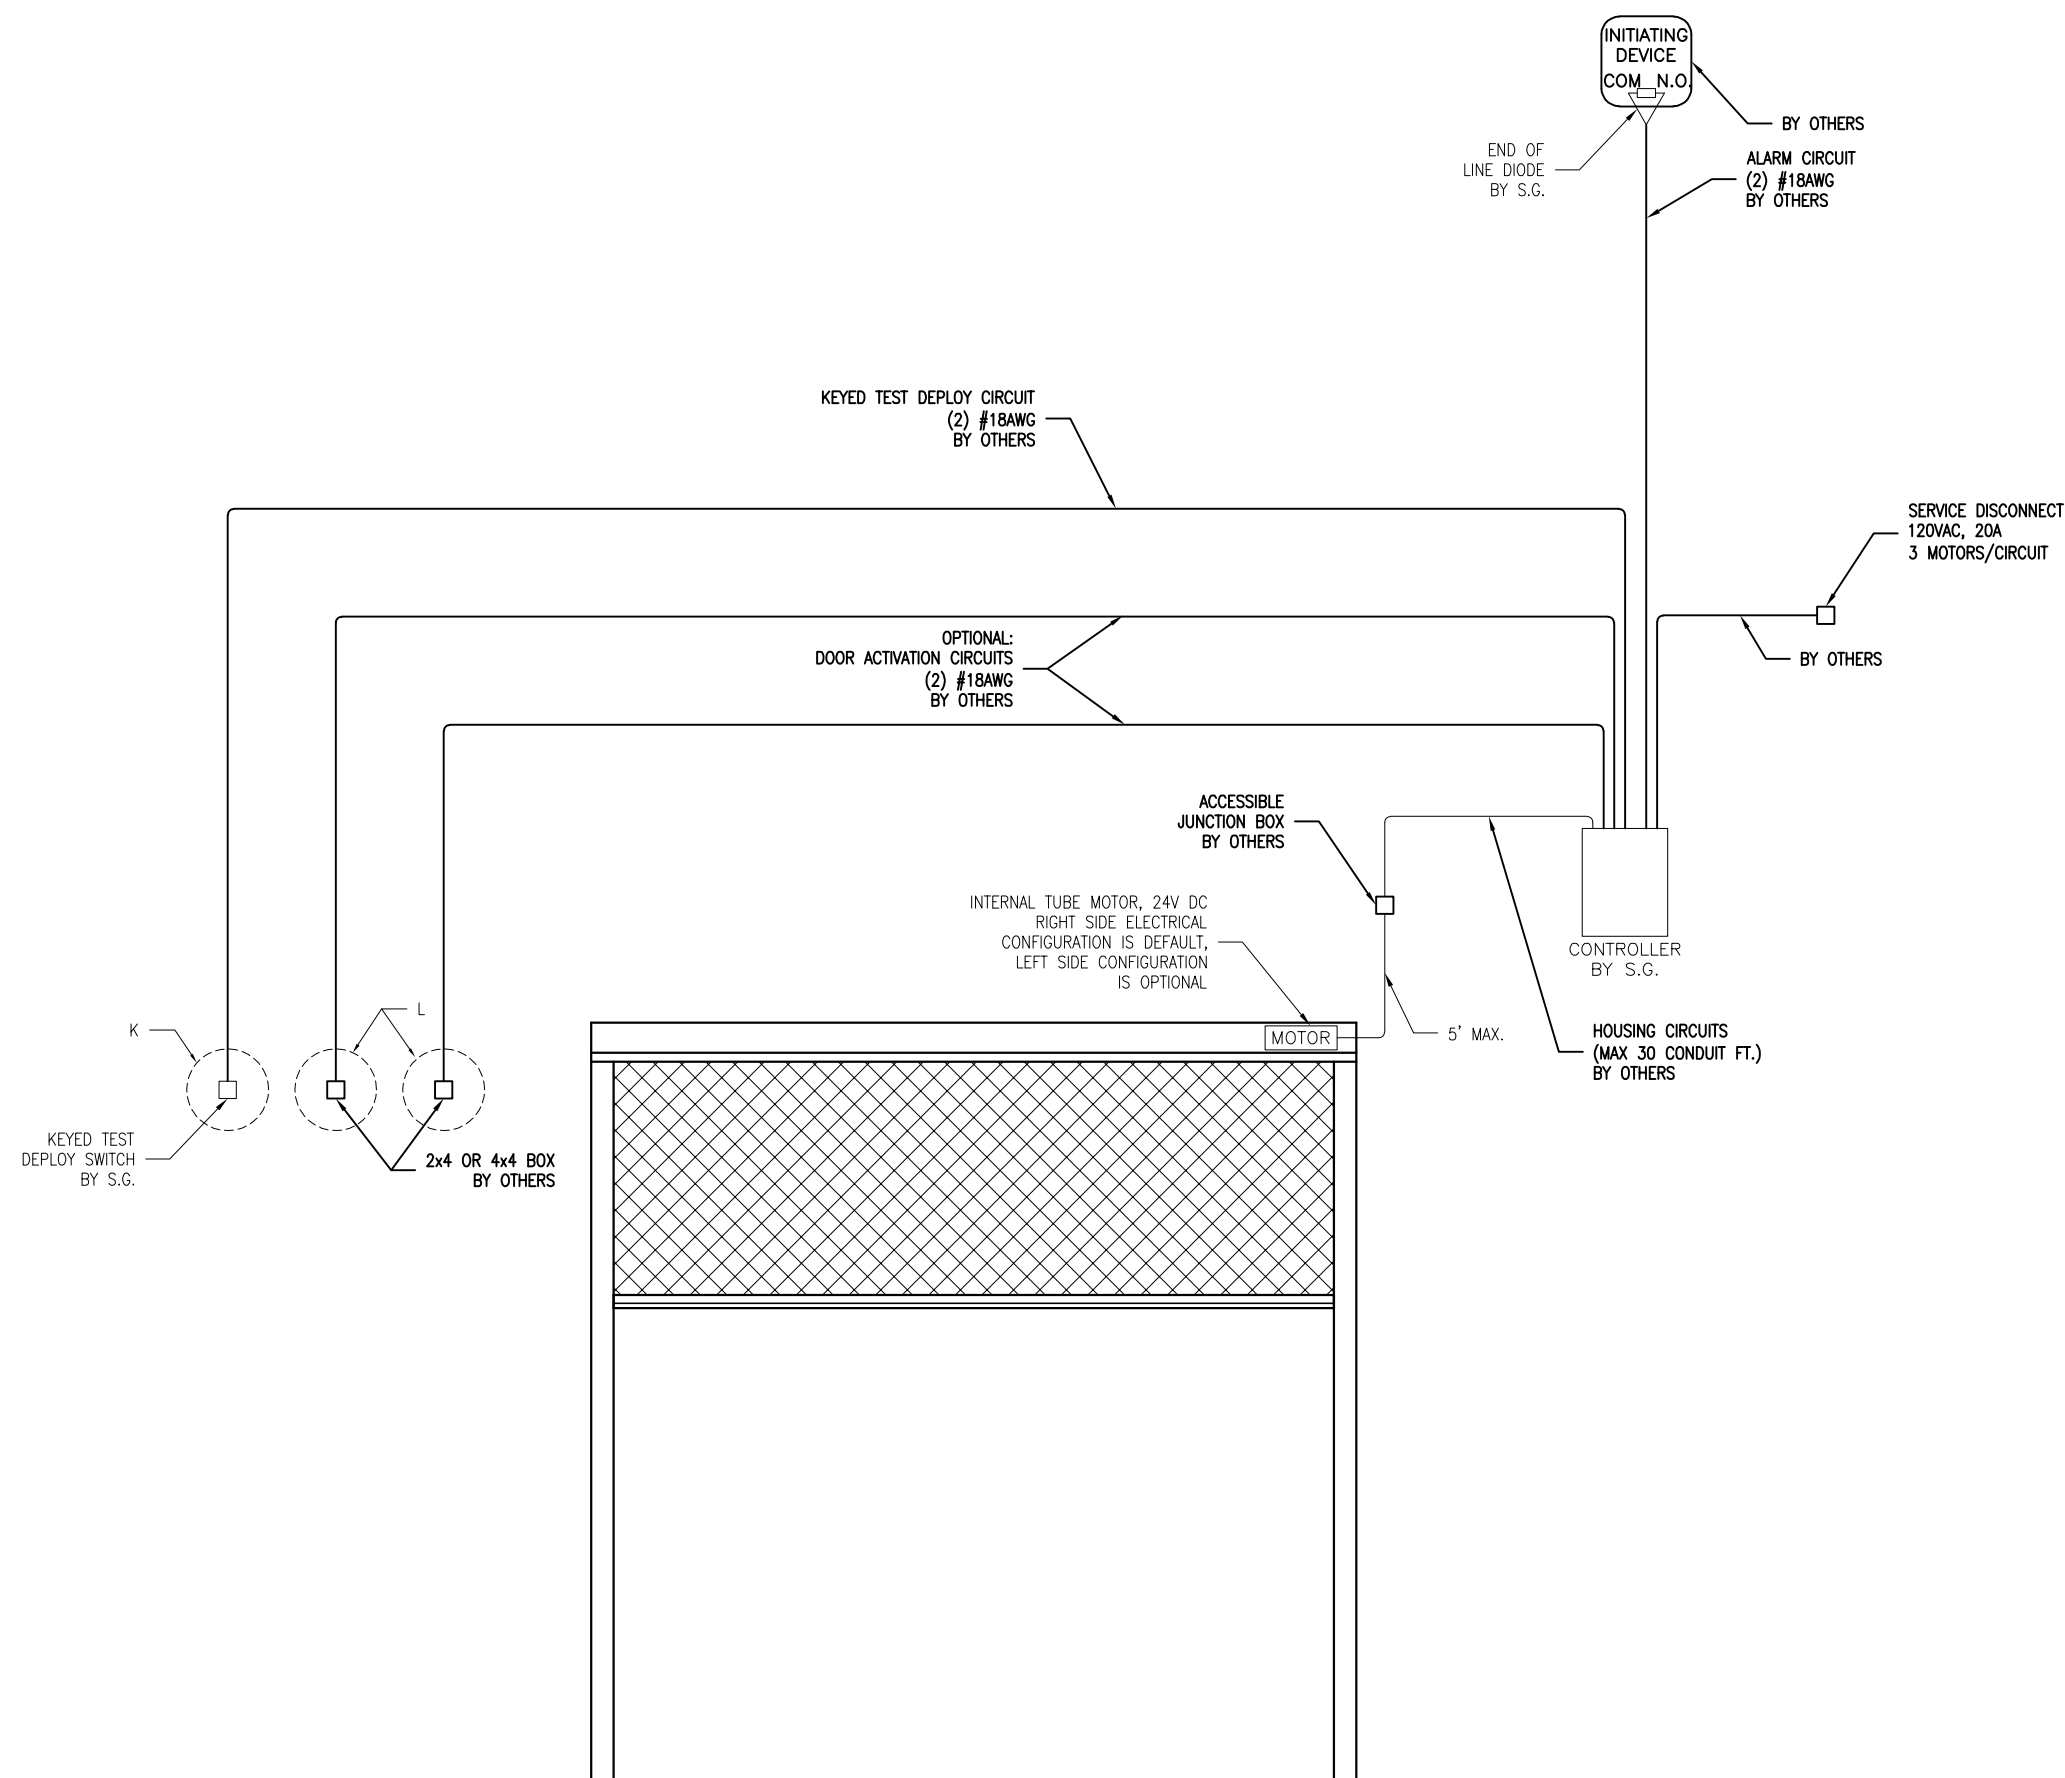

12 ELECTRICAL DIAGRAM
SCALE: 3/8" = 1'-0"

REVISION		
REVISION NUMBER	REVISION DATE	REVISION DESCRIPTION
D1	5.1.17	INITIAL RELEASE

QUOTE:
CONFIGURATION:
PROJECT:
DIST.:

DESIGN SET: D1	SIZE B
MODEL: M2100	SHEET
DRAWN: RB	5.5.2017
DD5/5	